


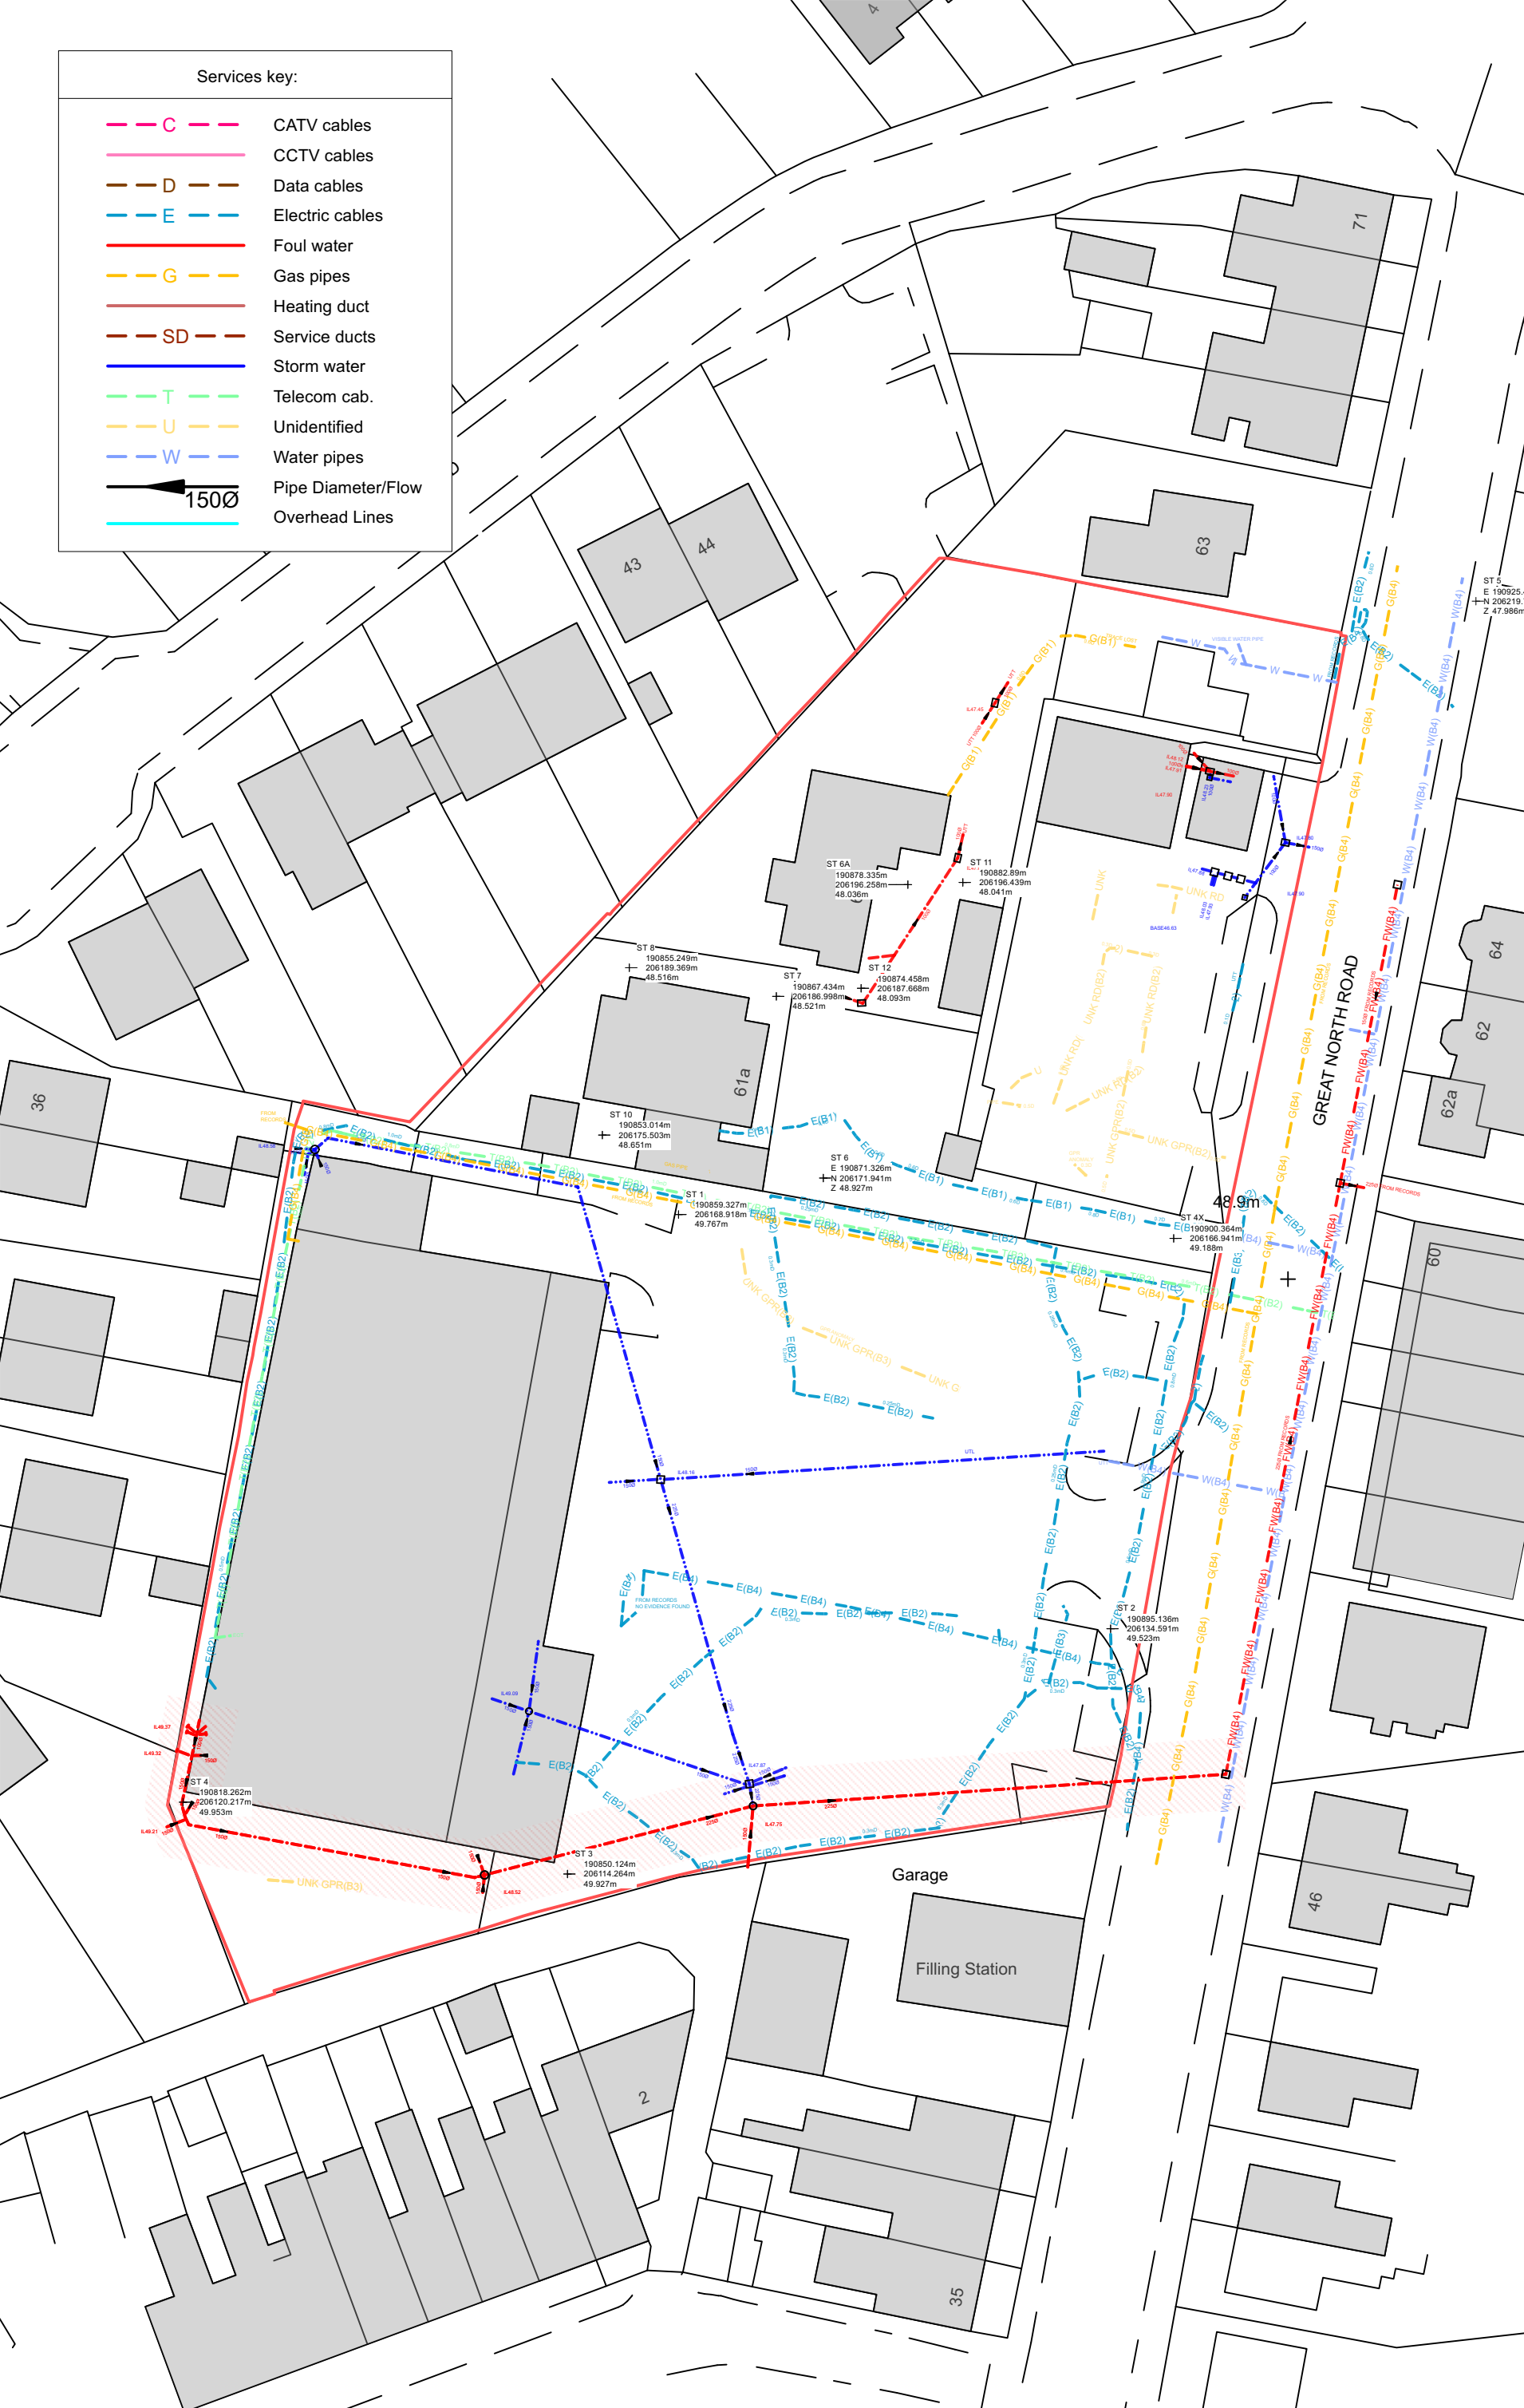

Services key:

- **C** CATV cables
- **CCTV** cables
- **D** Data cables
- **E** Electric cables
- **F** Foul water
- **G** Gas pipes
- **H** Heating duct
- **SD** Service ducts
- **S** Storm water
- **T** Telecom cab.
- **U** Unidentified
- **W** Water pipes
- **Ø** Pipe Diameter/Flow
- **OL** Overhead Lines



Rev.	Date	Description	Drawn

htcarchitects
York Place Studio
8 Britannia Street
Leeds
LS1 2DZ

T: (0113) 244 3457
W: www.htcarchitects.co.uk
E: info@htcarchitects.co.uk

client
Lidl GB Ltd.



project
Milford Haven

drawing title
Existing Utility Plan

date **October 2023**
status **Planning**
scale **1:500 @ A3**
drawn **NG** checked **BM**
job no. **3200** dwg no. **P402** rev.

